



Facilities Planning & Construction
 Physical Plant
 1 University Circle
 Macomb, IL 61455-1390
 Phone: 309/298-1834
 Fax: 309/298-1695

Project Title:

Description:

Location:
 CURRENS HALL
 MACOMB, IL

Sheet Title:

Date: 6/10/00
 Revised: 6/06/02
 6/23/04 DS, 5/20/08
 9/22/20 DB


Drawn By: MW/JN
 Checked By:

Sheet No.

GR-22B

of Sheet(s)

WIU Job Number :

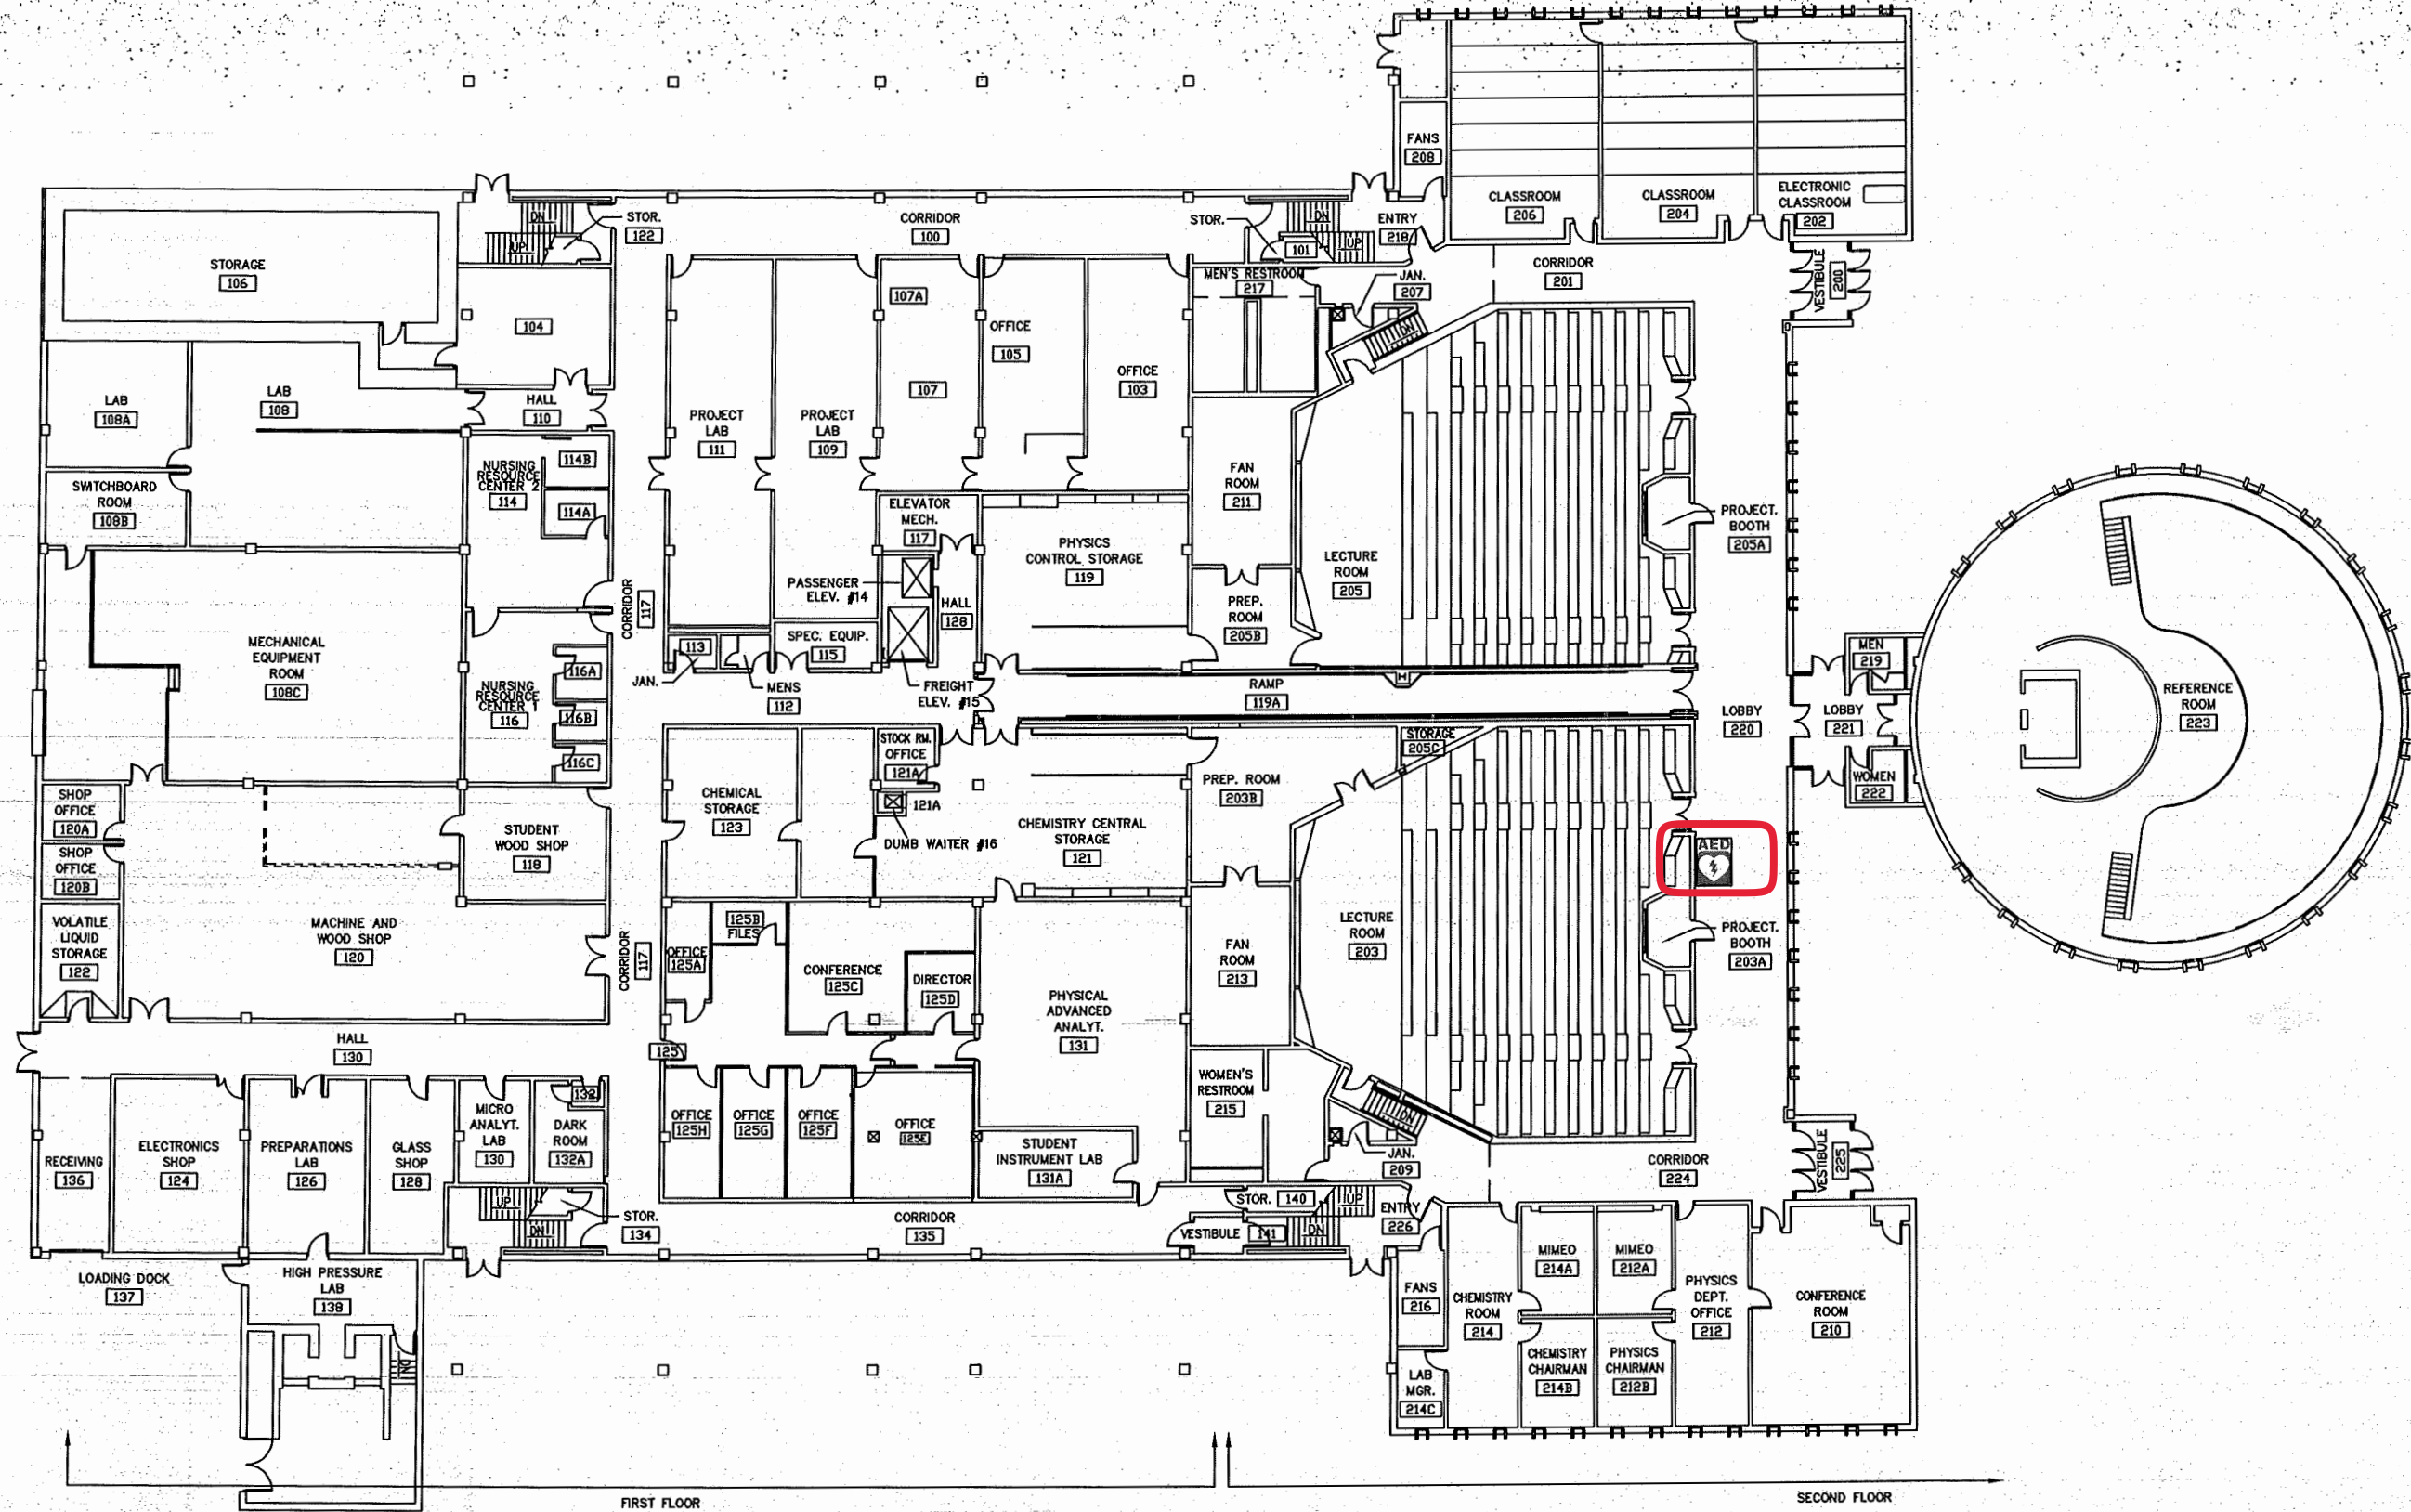

FIRST AND SECOND FLOOR PLAN

SCALE: NTS

