

Facilities Planning & Construction

Physical Plant  
 1 University Circle  
 Macomb, IL 61455-1390  
 Phone: 309/298-1834  
 Fax: 309/298-1695

Project Title:

Description:

Location:  
 BROPHY HALL  
 MACOMB, IL

Sheet Title:



Date: 7/12/00  
 Revised: 6/06/02  
 10/3/08 DLS, 9/21/20 DB

Drawn By: MW/JN  
 Checked By: \_\_\_\_\_

Sheet No.:  
**GR-14**

of . Sheet(s)

WIU Job Number :

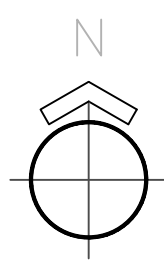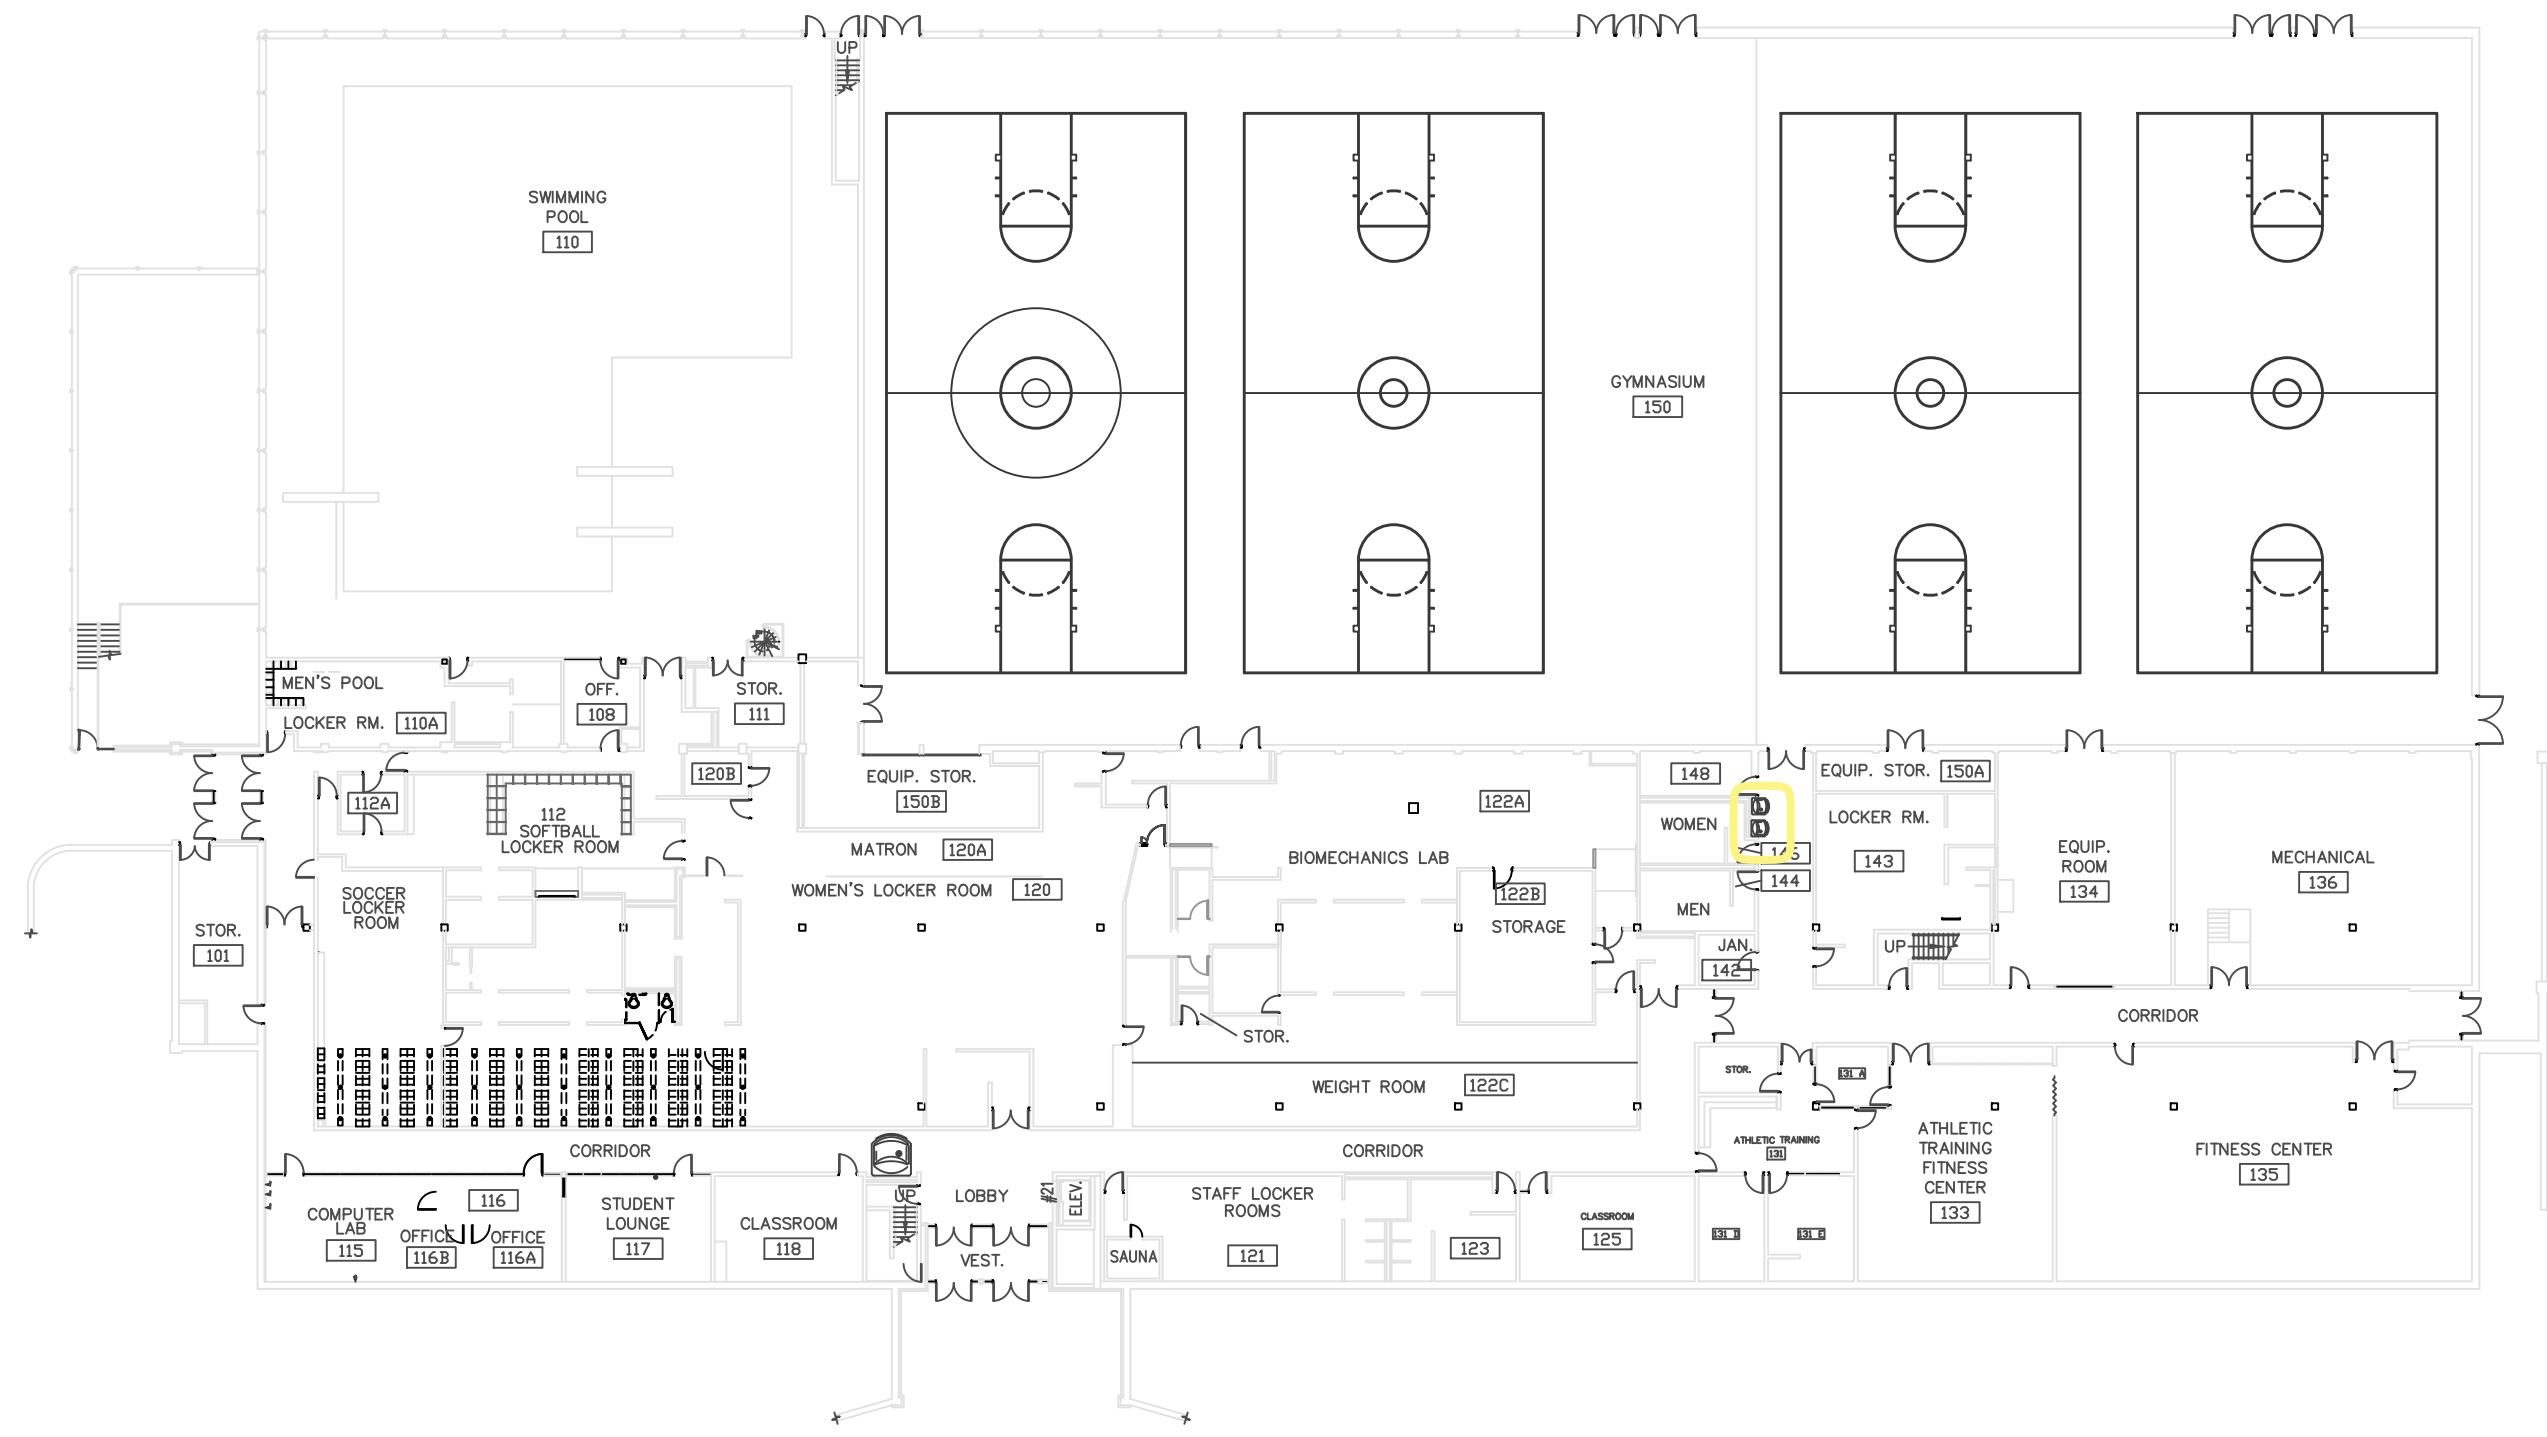

LOWER FLOOR PLAN

SCALE : NTS

