



Facilities Planning & Construction

Physical Plant
1 University Circle
Macomb, IL 61455-1390
Phone: 309/298-1834
Fax: 309/298-1695

Project Title:

Description:

Location:

SIMPKINS HALL
MACOMB, IL

Sheet Title:

Date: 7/11/00

Revised: 6/20/02

5/3/12 DS, 9/24/20 DB

Drawn By: MW/JN


Checked By:

Sheet No.:

GR-101

of Sheet(s)

WIU Job Number :

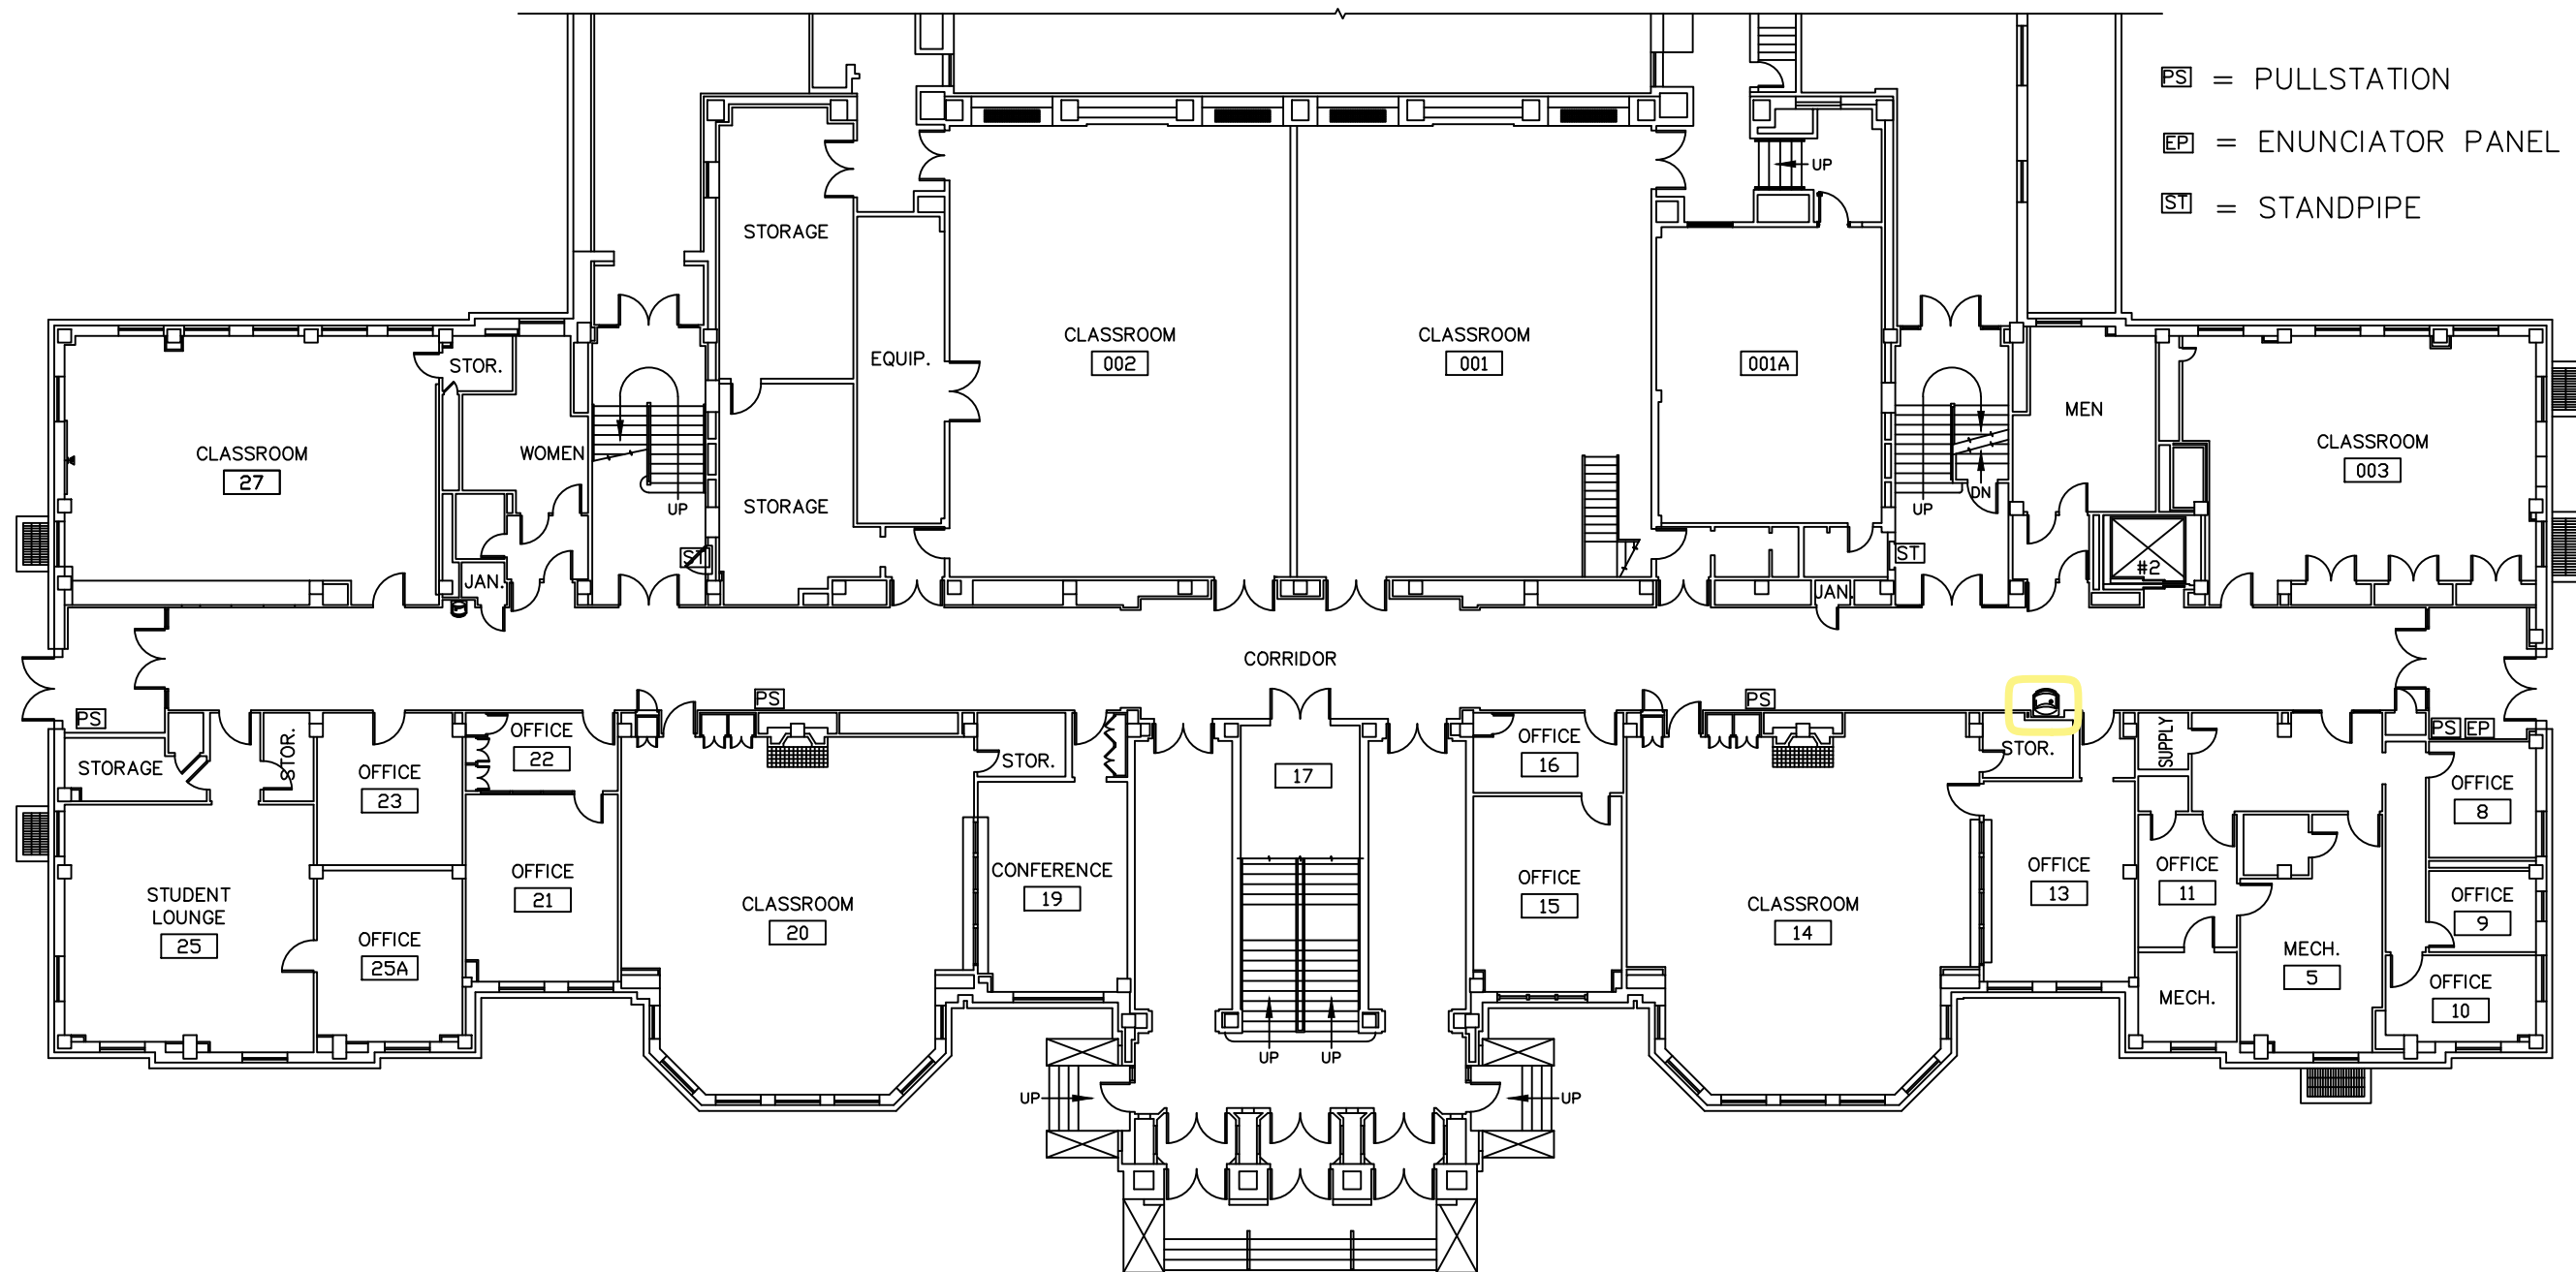

SIMPKINS HALL GROUND FLOOR PLAN

SCALE : NTS

